




"Golden grain" coffee shop interior design, for unit Kingsway, BR49 JF

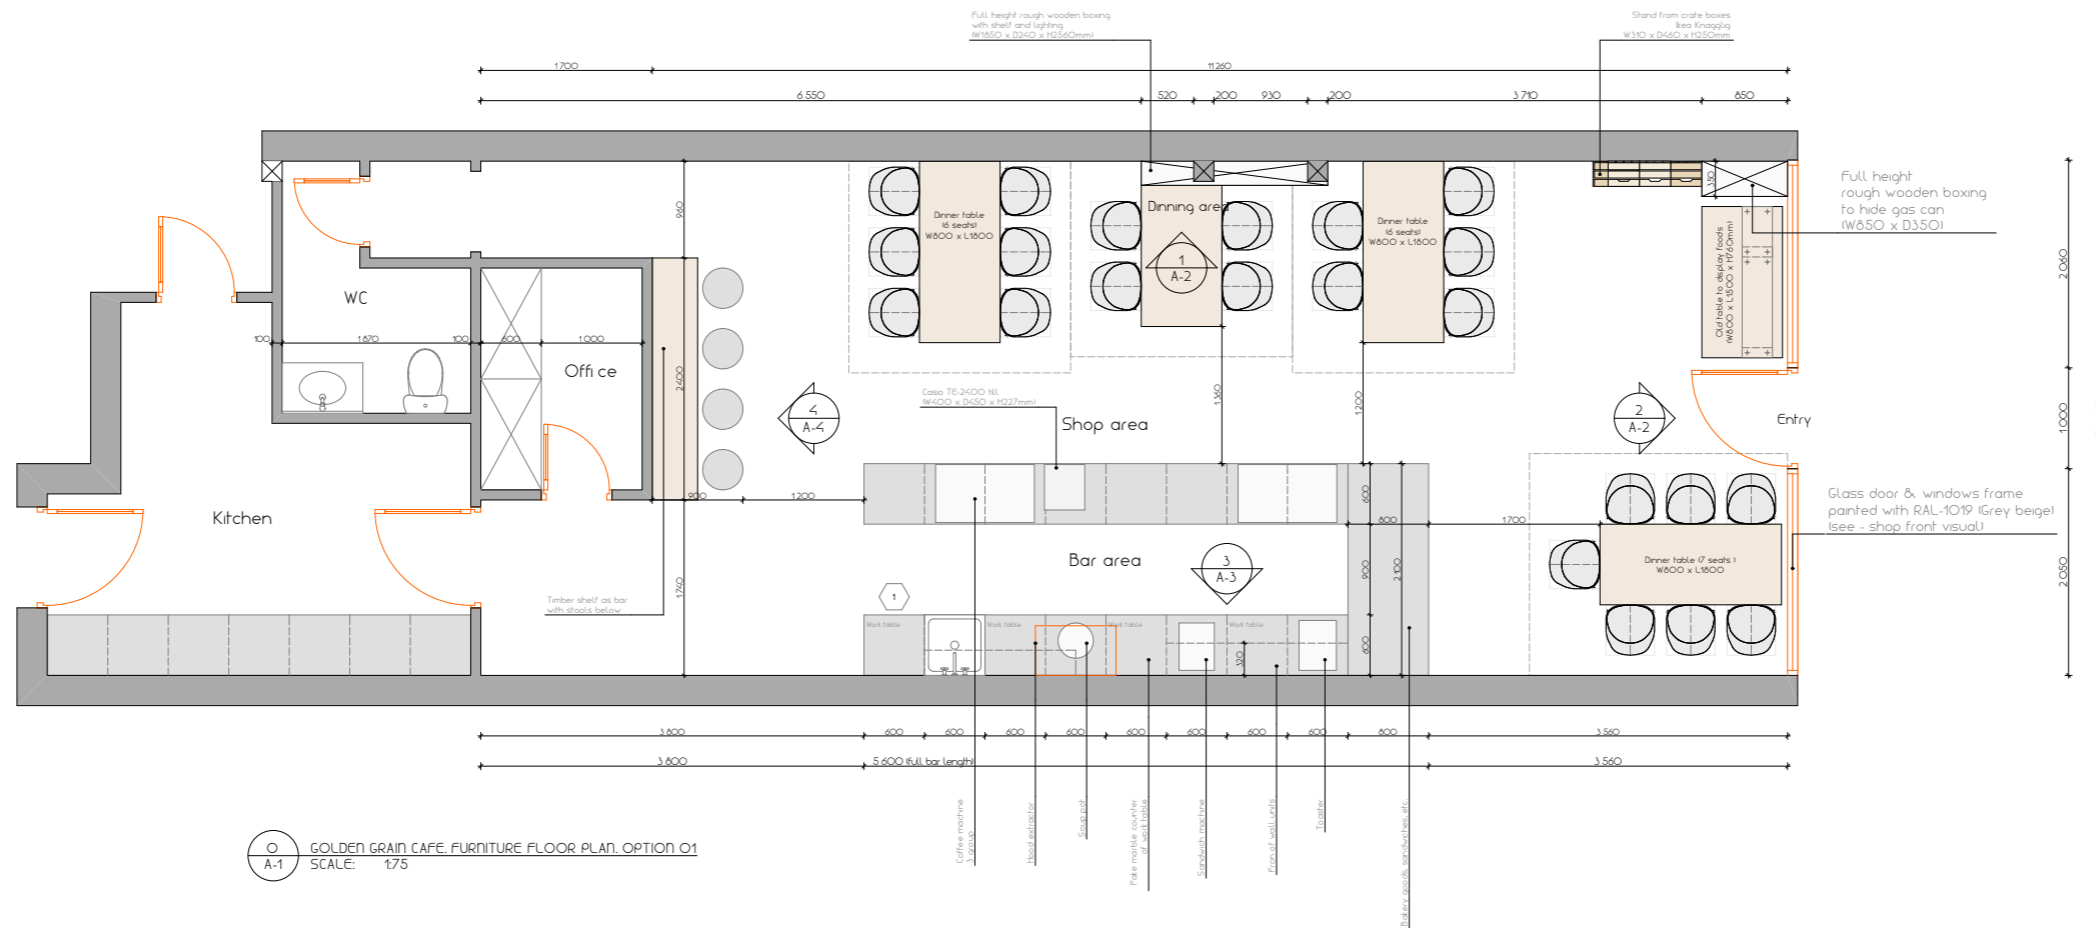


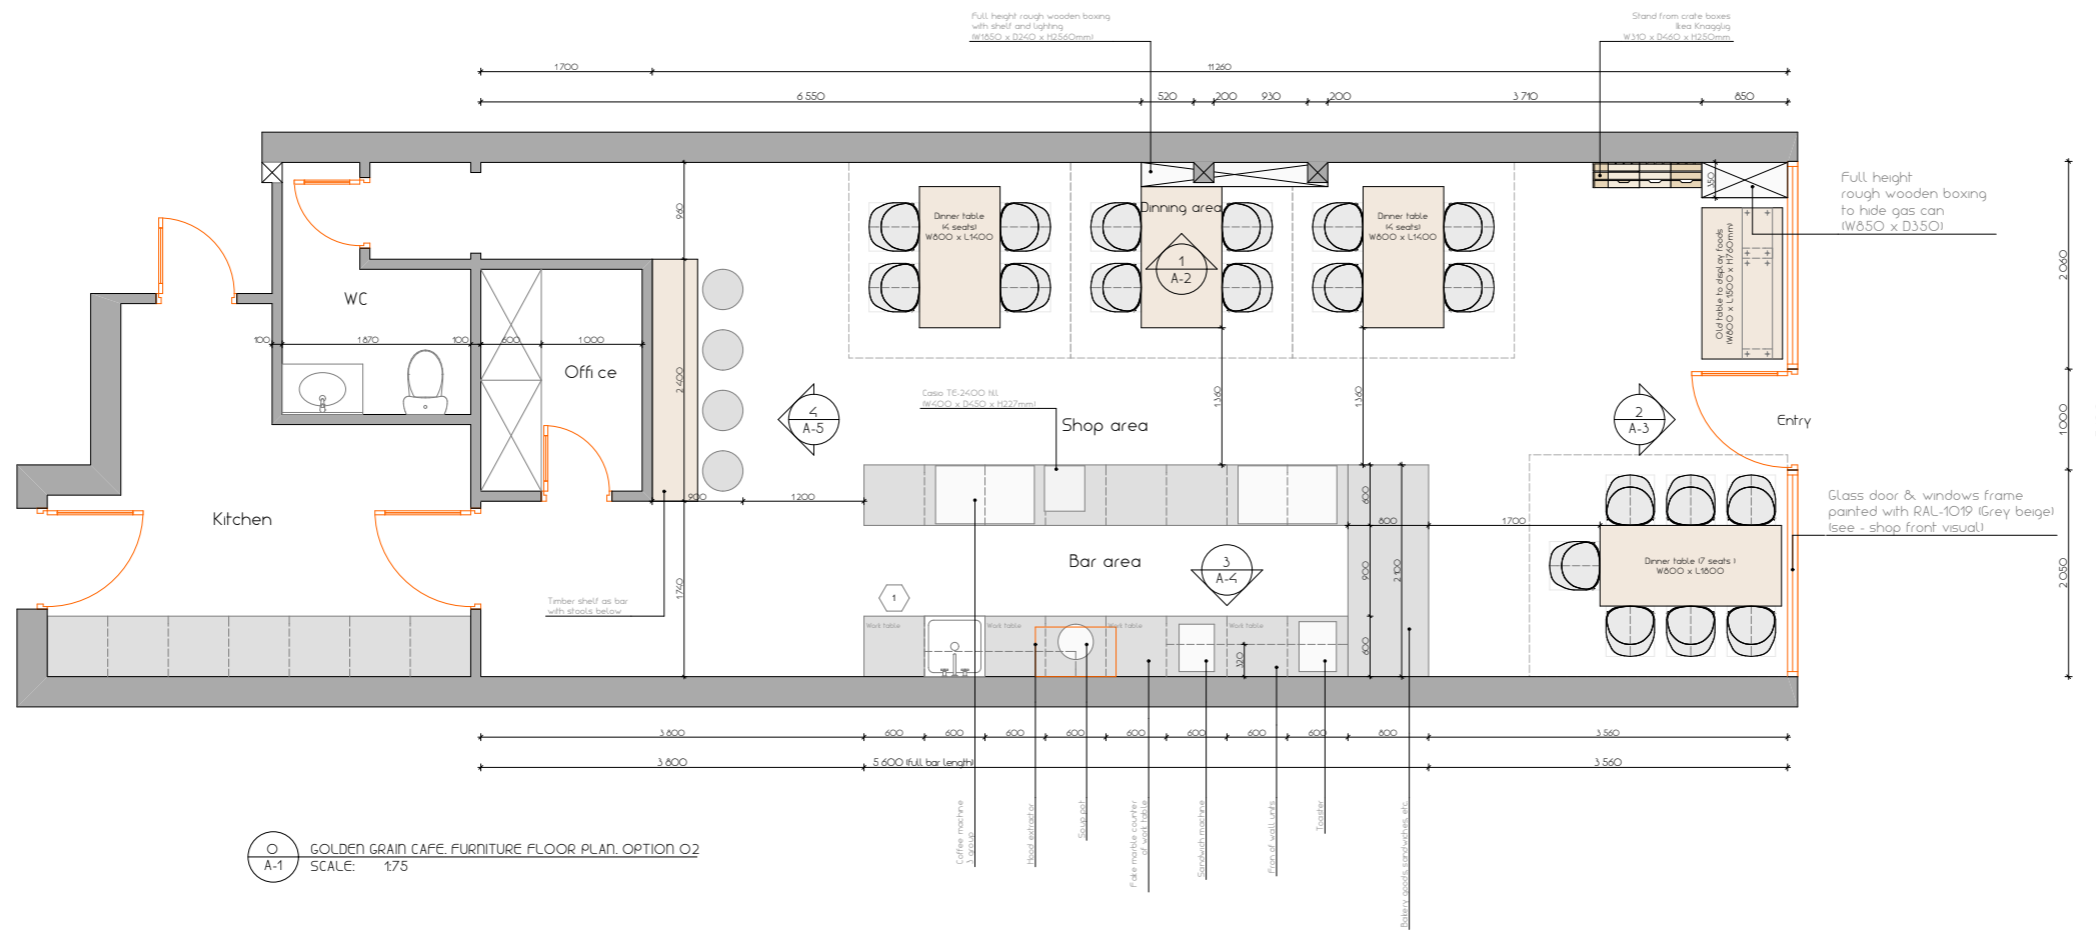


"Golden grain" coffee shop interior design, for unit Kingsway, BR49JF

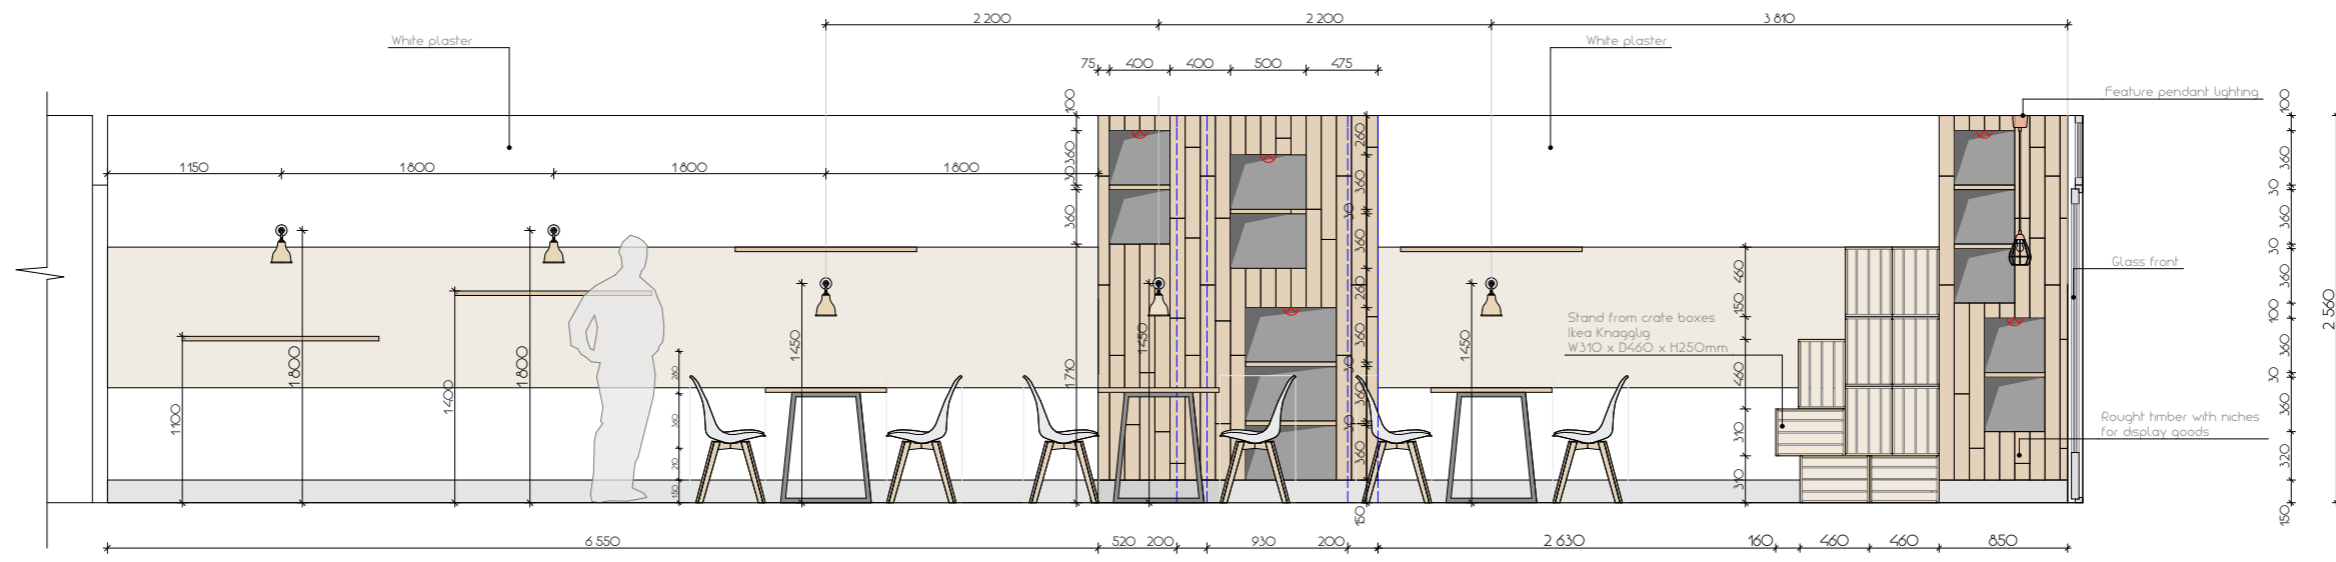

1 ELEVATION SEATING WALL  
A-2 SCALE: 1:50


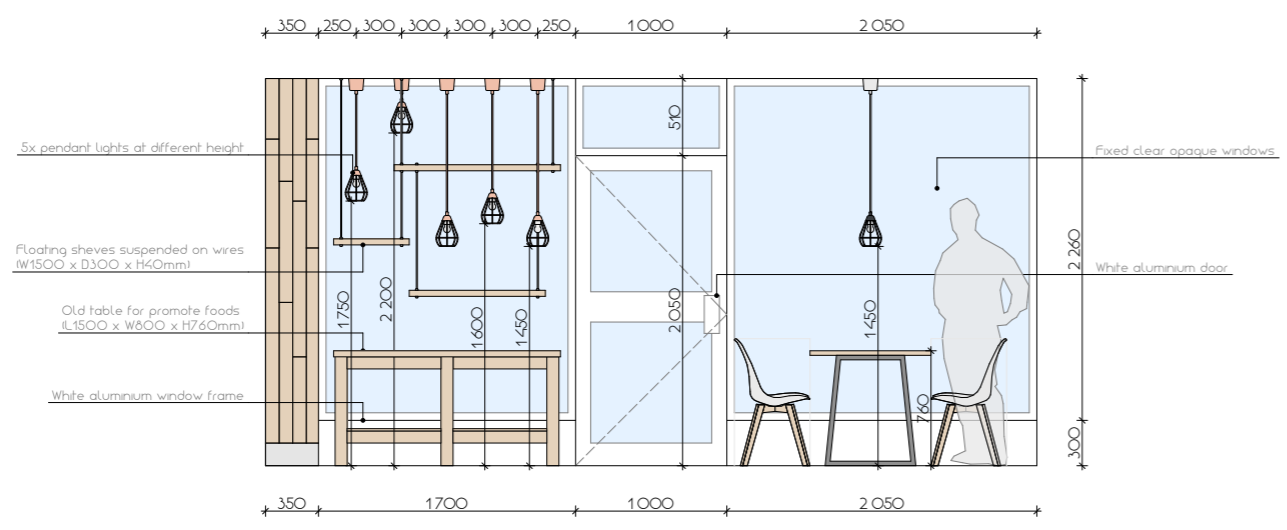


2 ELEVATION ENTRY WALL OPTION 01  
A-2 SCALE: 1:50

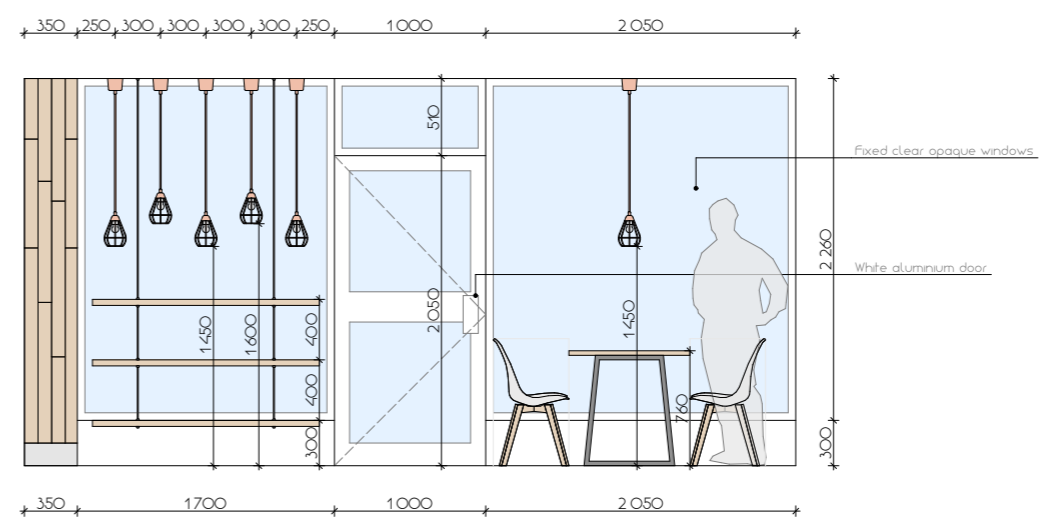


2 ELEVATION ENTRY WALL OPTION 02  
A-2 SCALE: 1:50

"Golden grain" coffee shop interior design, for unit Kingsway, BR49JF

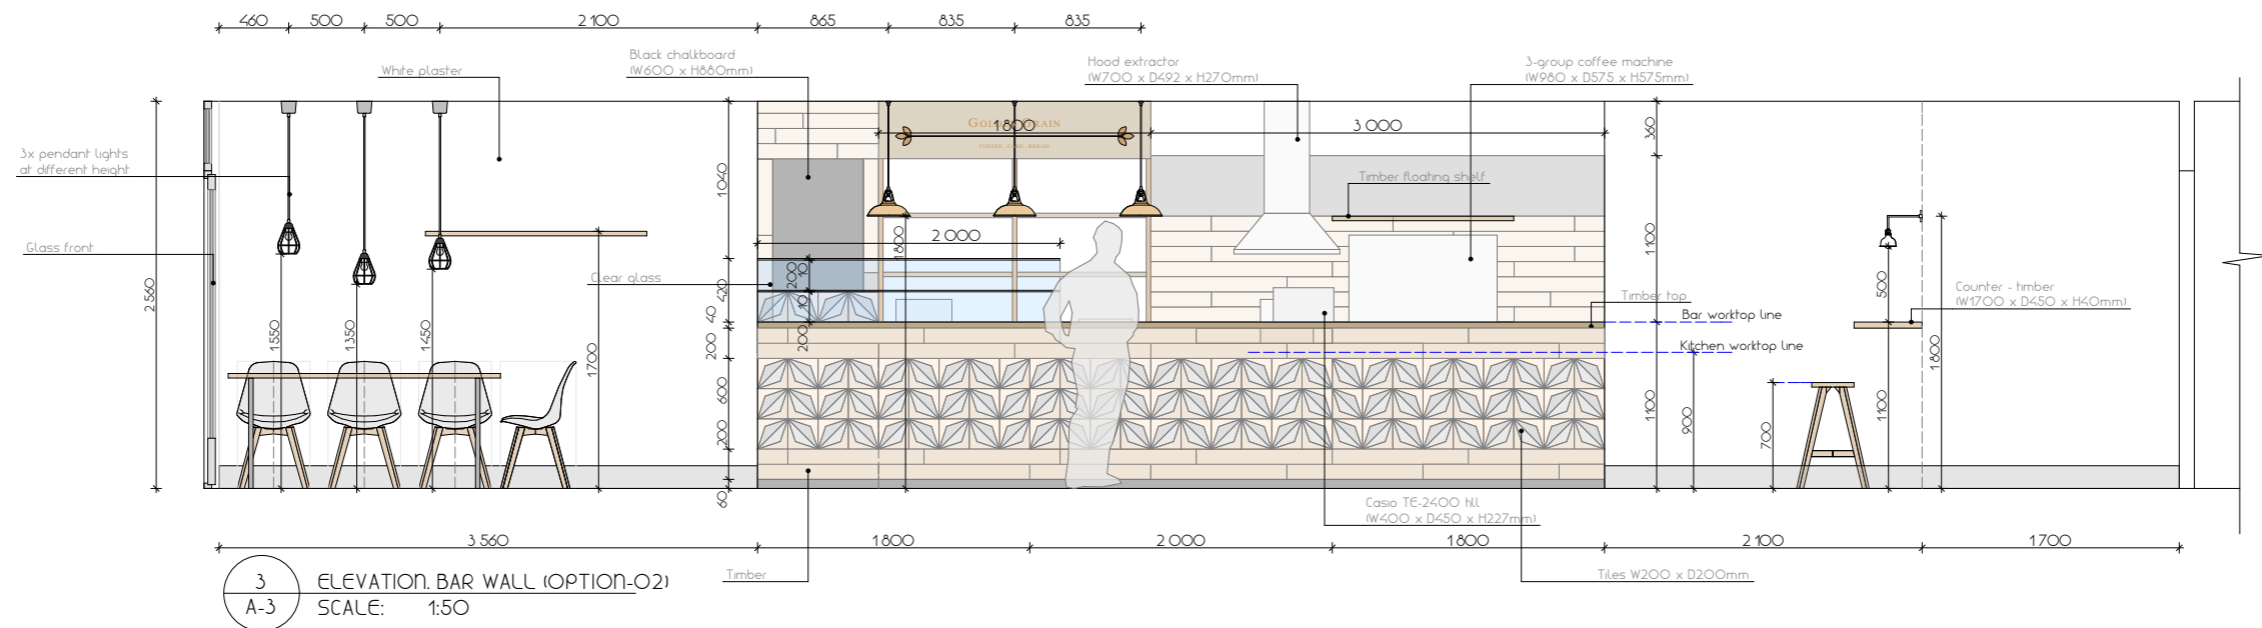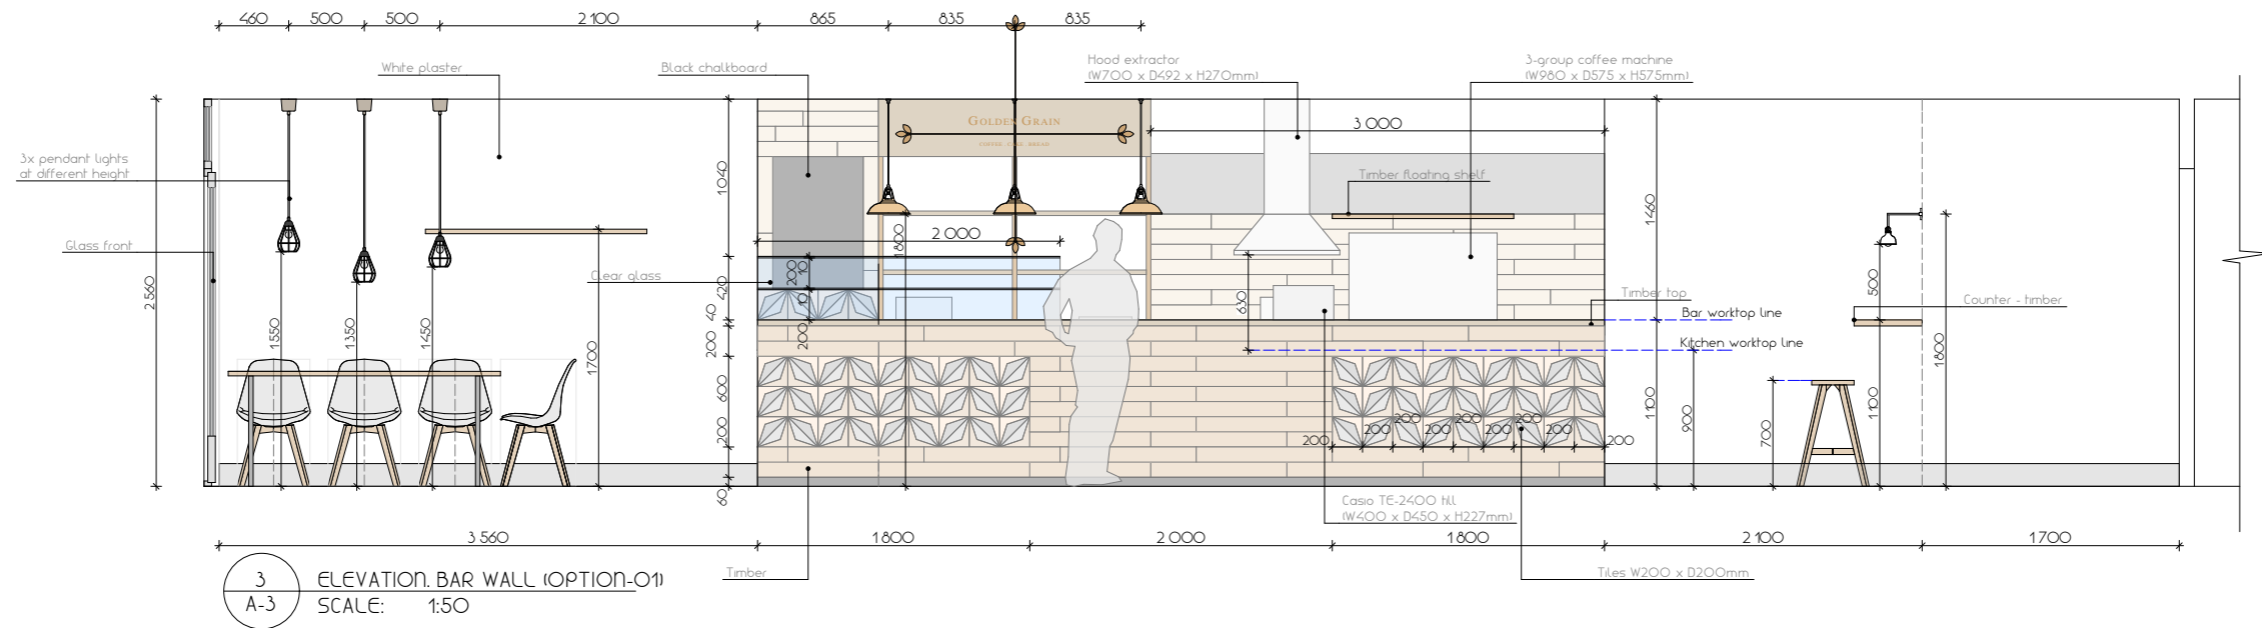


"Golden grain" coffee shop interior design, for unit Kingsway, BR49 JF

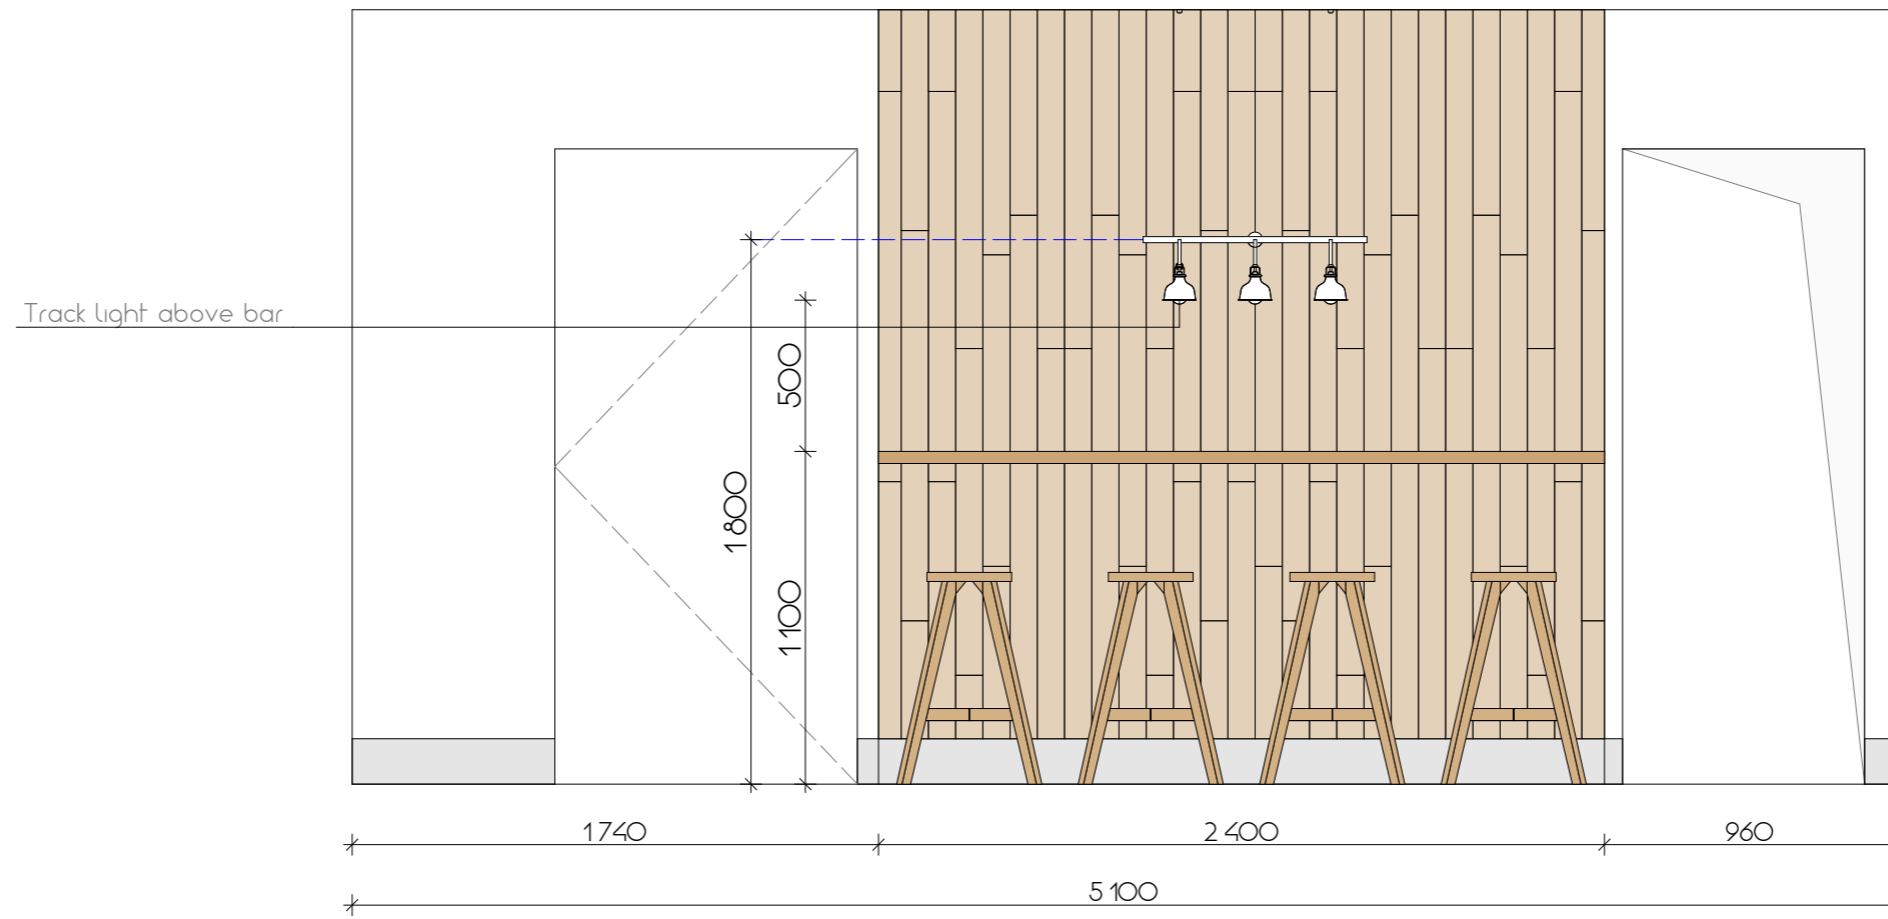

4  
A-4

ELEVATION. OFFICE WALL  
SCALE: 1:25

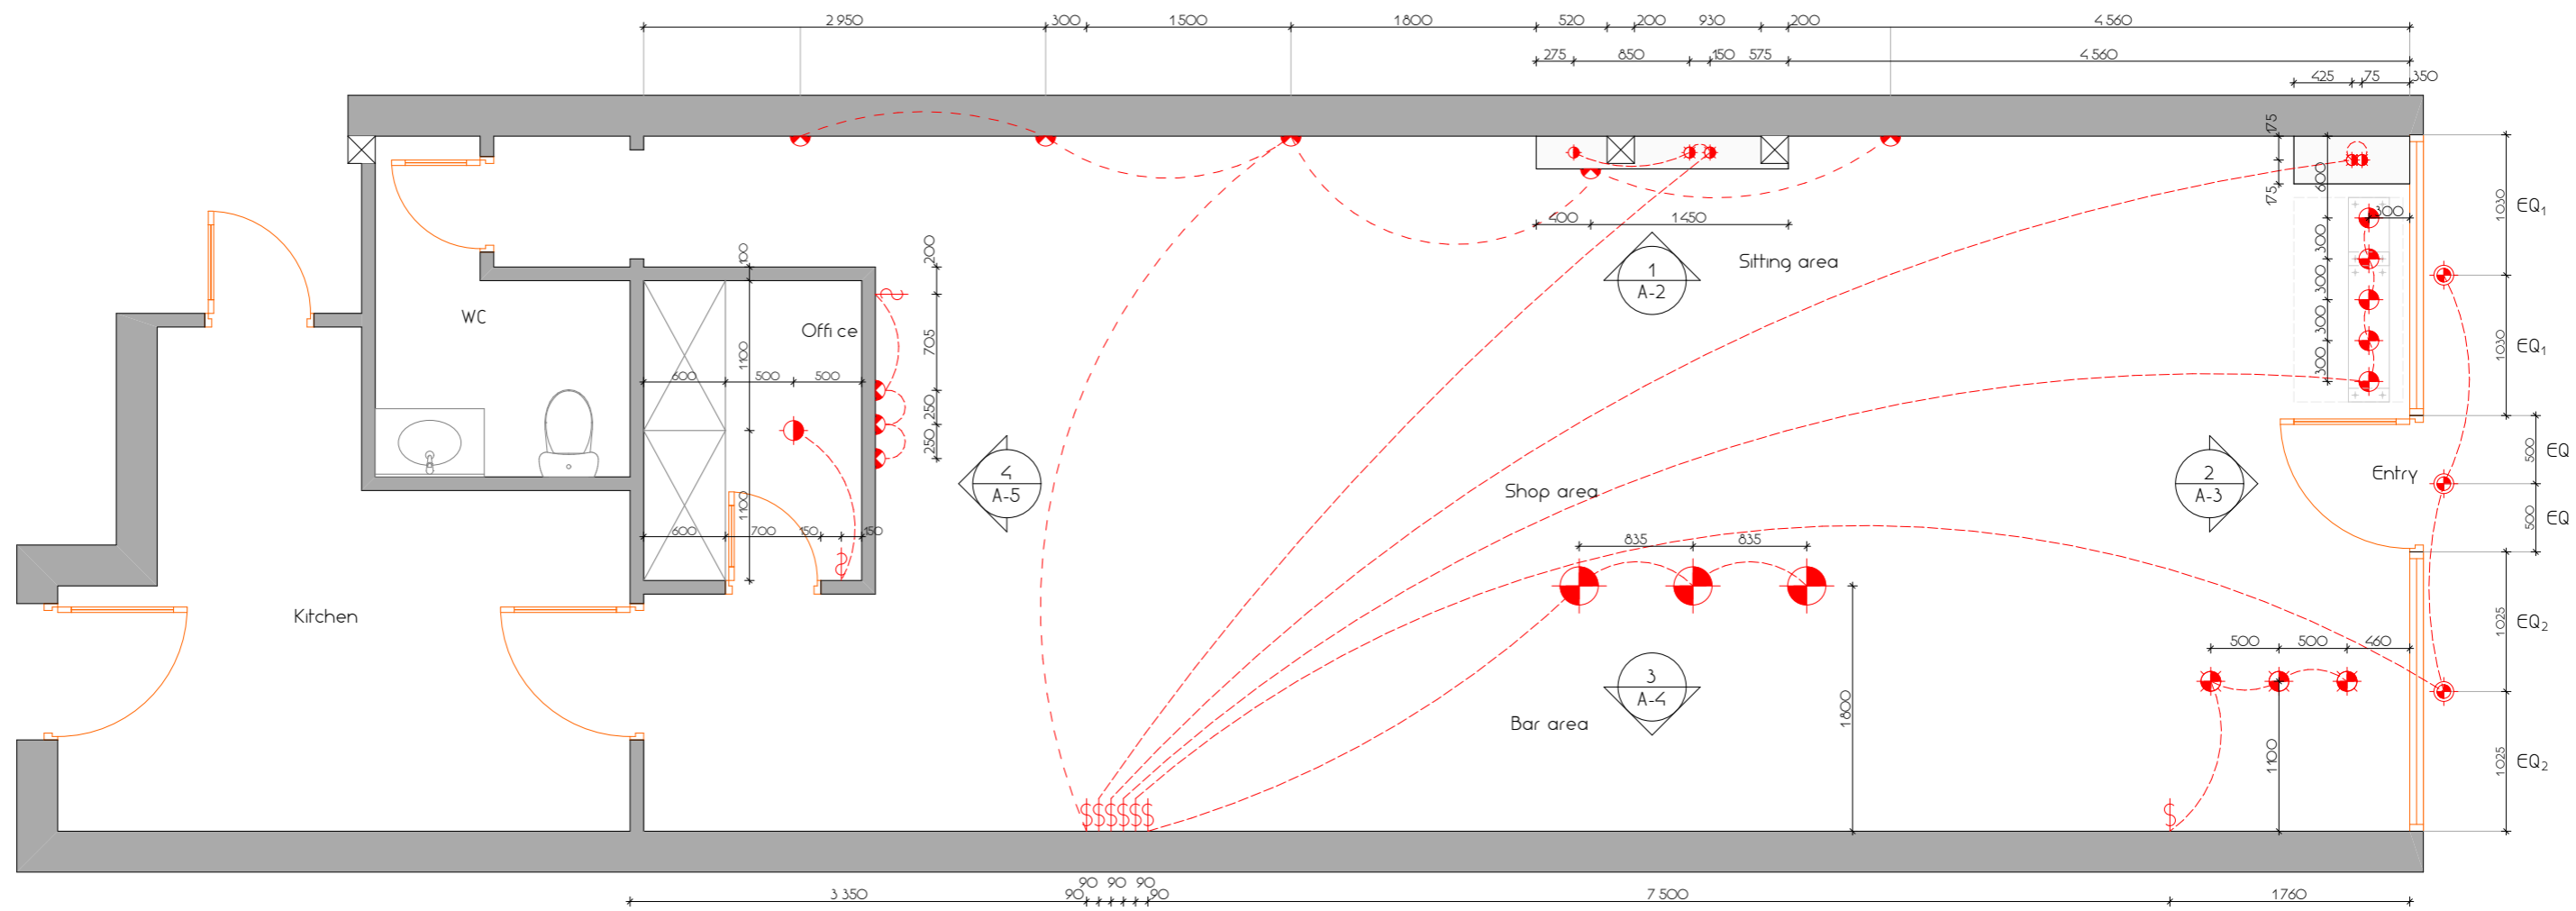


6 GOLDEN GRAIN CAFE. LIGHTING PLAN  
A-6 SCALE: 1:75

ELECTRICAL LEGEND	
\$	LIGHT SWITCH
⊙	EXTERIOR LIGHT
⊕	CEILING MOUNTED LIGHT
⊗	CEILING PENDANT HANGING LIGHT
◐	INTERNAL WALL MOUNTED LIGHT
◑	LOW VOLTAGE LIGHT POINT

"Golden grain" coffee shop interior design, for unit Kingsway, BR49JF



5 ELEVATION, EXISTING SHOP FRONT  
SCALE: 1:50

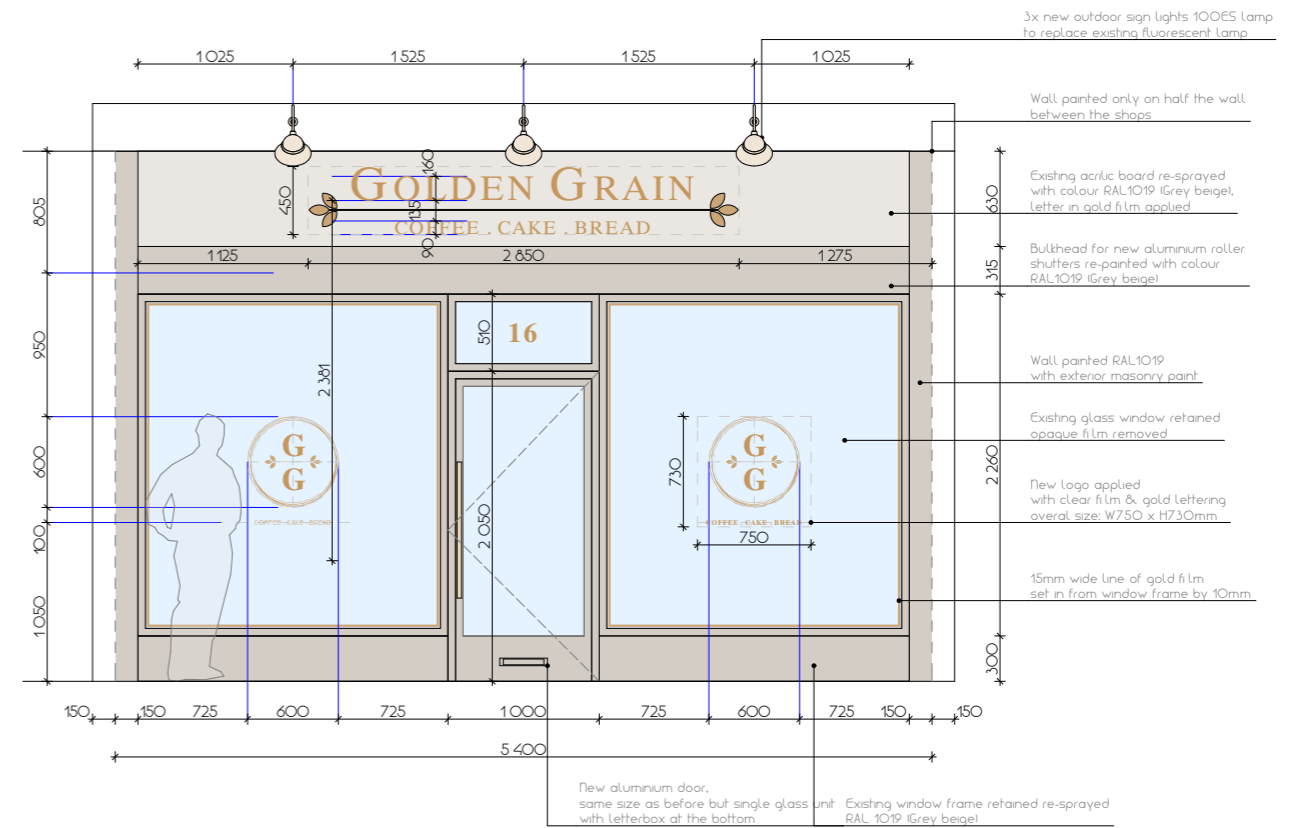

6 ELEVATION, PROPOSED SHOP FRONT  
SCALE: 1:50

SCALE: 1:50 @ A3

SCALE: 1:50 @ A3

**GOLDEN GRAIN**  
COFFEE.CAKE.BREAD

Proposed shop name



COFFEE.CAKE.BREAD

Proposed logo for windows

"Golden grain" coffee shop interior design, for unit Kingsway, BR49JF